

## Like for Like Bathroom Remodel


	Layout Page Table
A1.0	3d Overview
A2.0	Rendering
A3.0	Furniture plan
A4.0	Elevation plan
A5.0	New Flooring plan



# Like for Like Bathroom Remodel

v1.3

DESIGNED BY:  
ROSSLE HOMES  
DESIGN & CONSTRUCTION

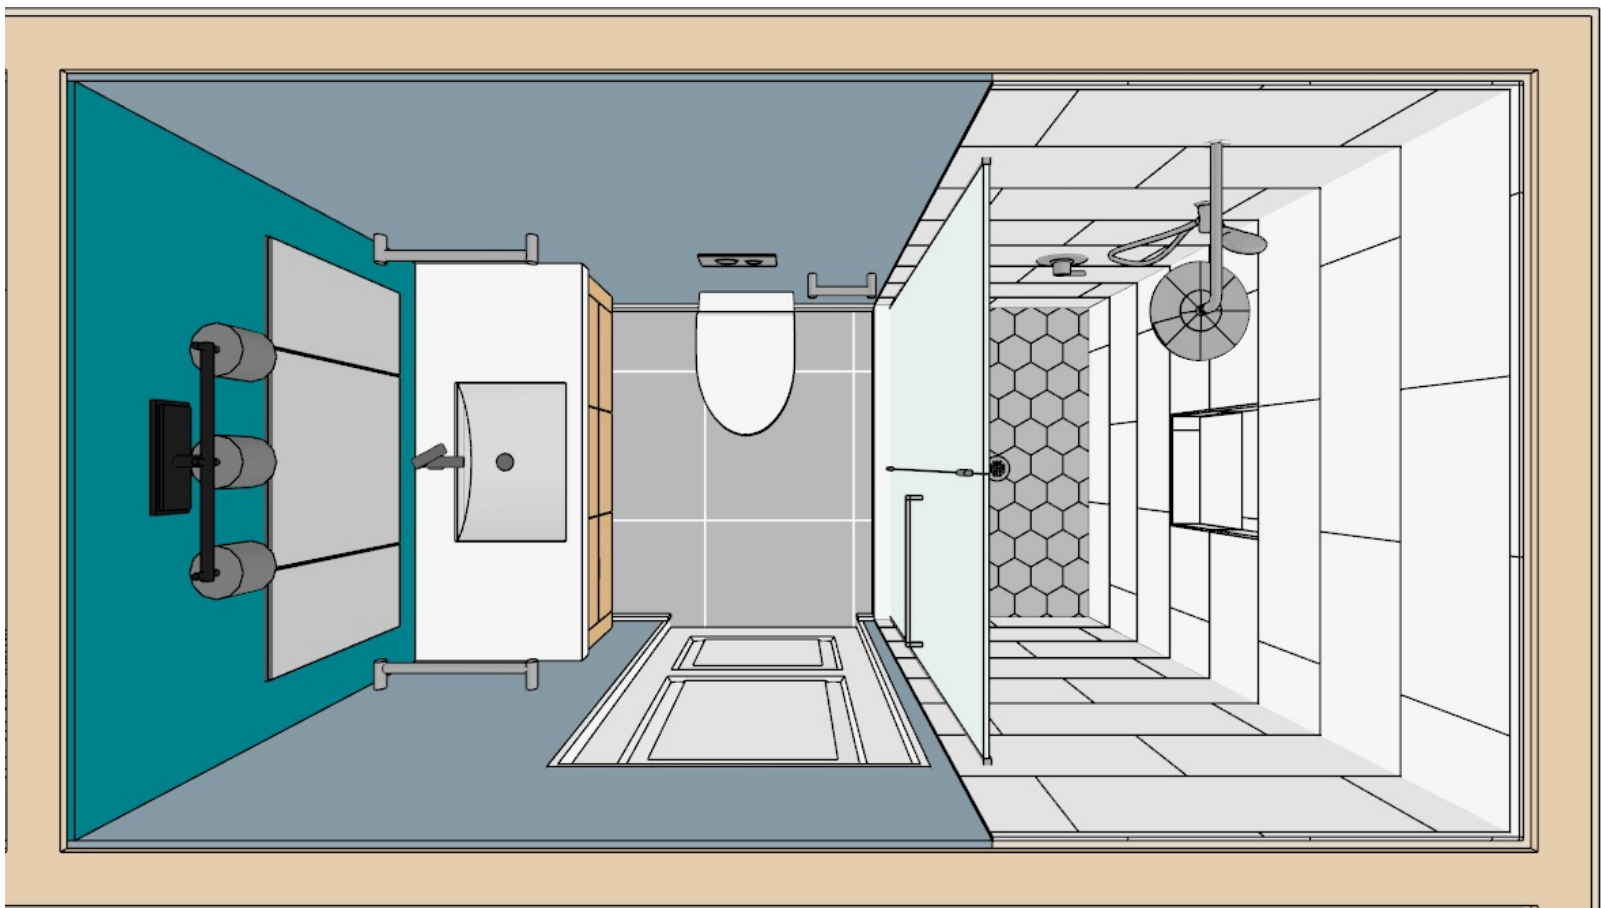

**3D OVERVIEW**

Note: this drawing is an artistic rendition interpretation of the general appearance of the design. All dimensions given are subject to verification on the job site and adjustment to fit job conditions.

Cabinet sizes are given to our standard lines and if the cabinet line you chose does not come in that size then it will be replaced with the closest standard size.

All cabinets are measured by external dimension of the box

Keep in mind that changing appliances (especially their size) or cabinets can lead to changes in the layout.

3d Overview

DRAWINGS PROVIDED BY:

DATE:

3/15/2023

SCALE@:

ANSI B  
(11"x17")

SHEET:

A1.0



**BATHROOM RENDERS**

Rendering

DRAWINGS PROVIDED BY:

DATE:

3/15/2023

SCALE@:

ANSI B  
(11"x17")

SHEET:

A2.0

**FURNITURE PLAN**


**1/2" = 1'**

**Verify all dimensions on the field**

**SCOPE OF WORK: LIKE FOR LIKE BATHROOM REMODEL. REPLACE ALL FIXTURES; INSTALL NEW TILED SHOWER WALLS AND PAN; INSTALL GLASS DOOR; REPLACE VANITY.**

v1.3

DESIGNED BY:  
ROSSLE HOMES  
DESIGN & CONSTRUCTION

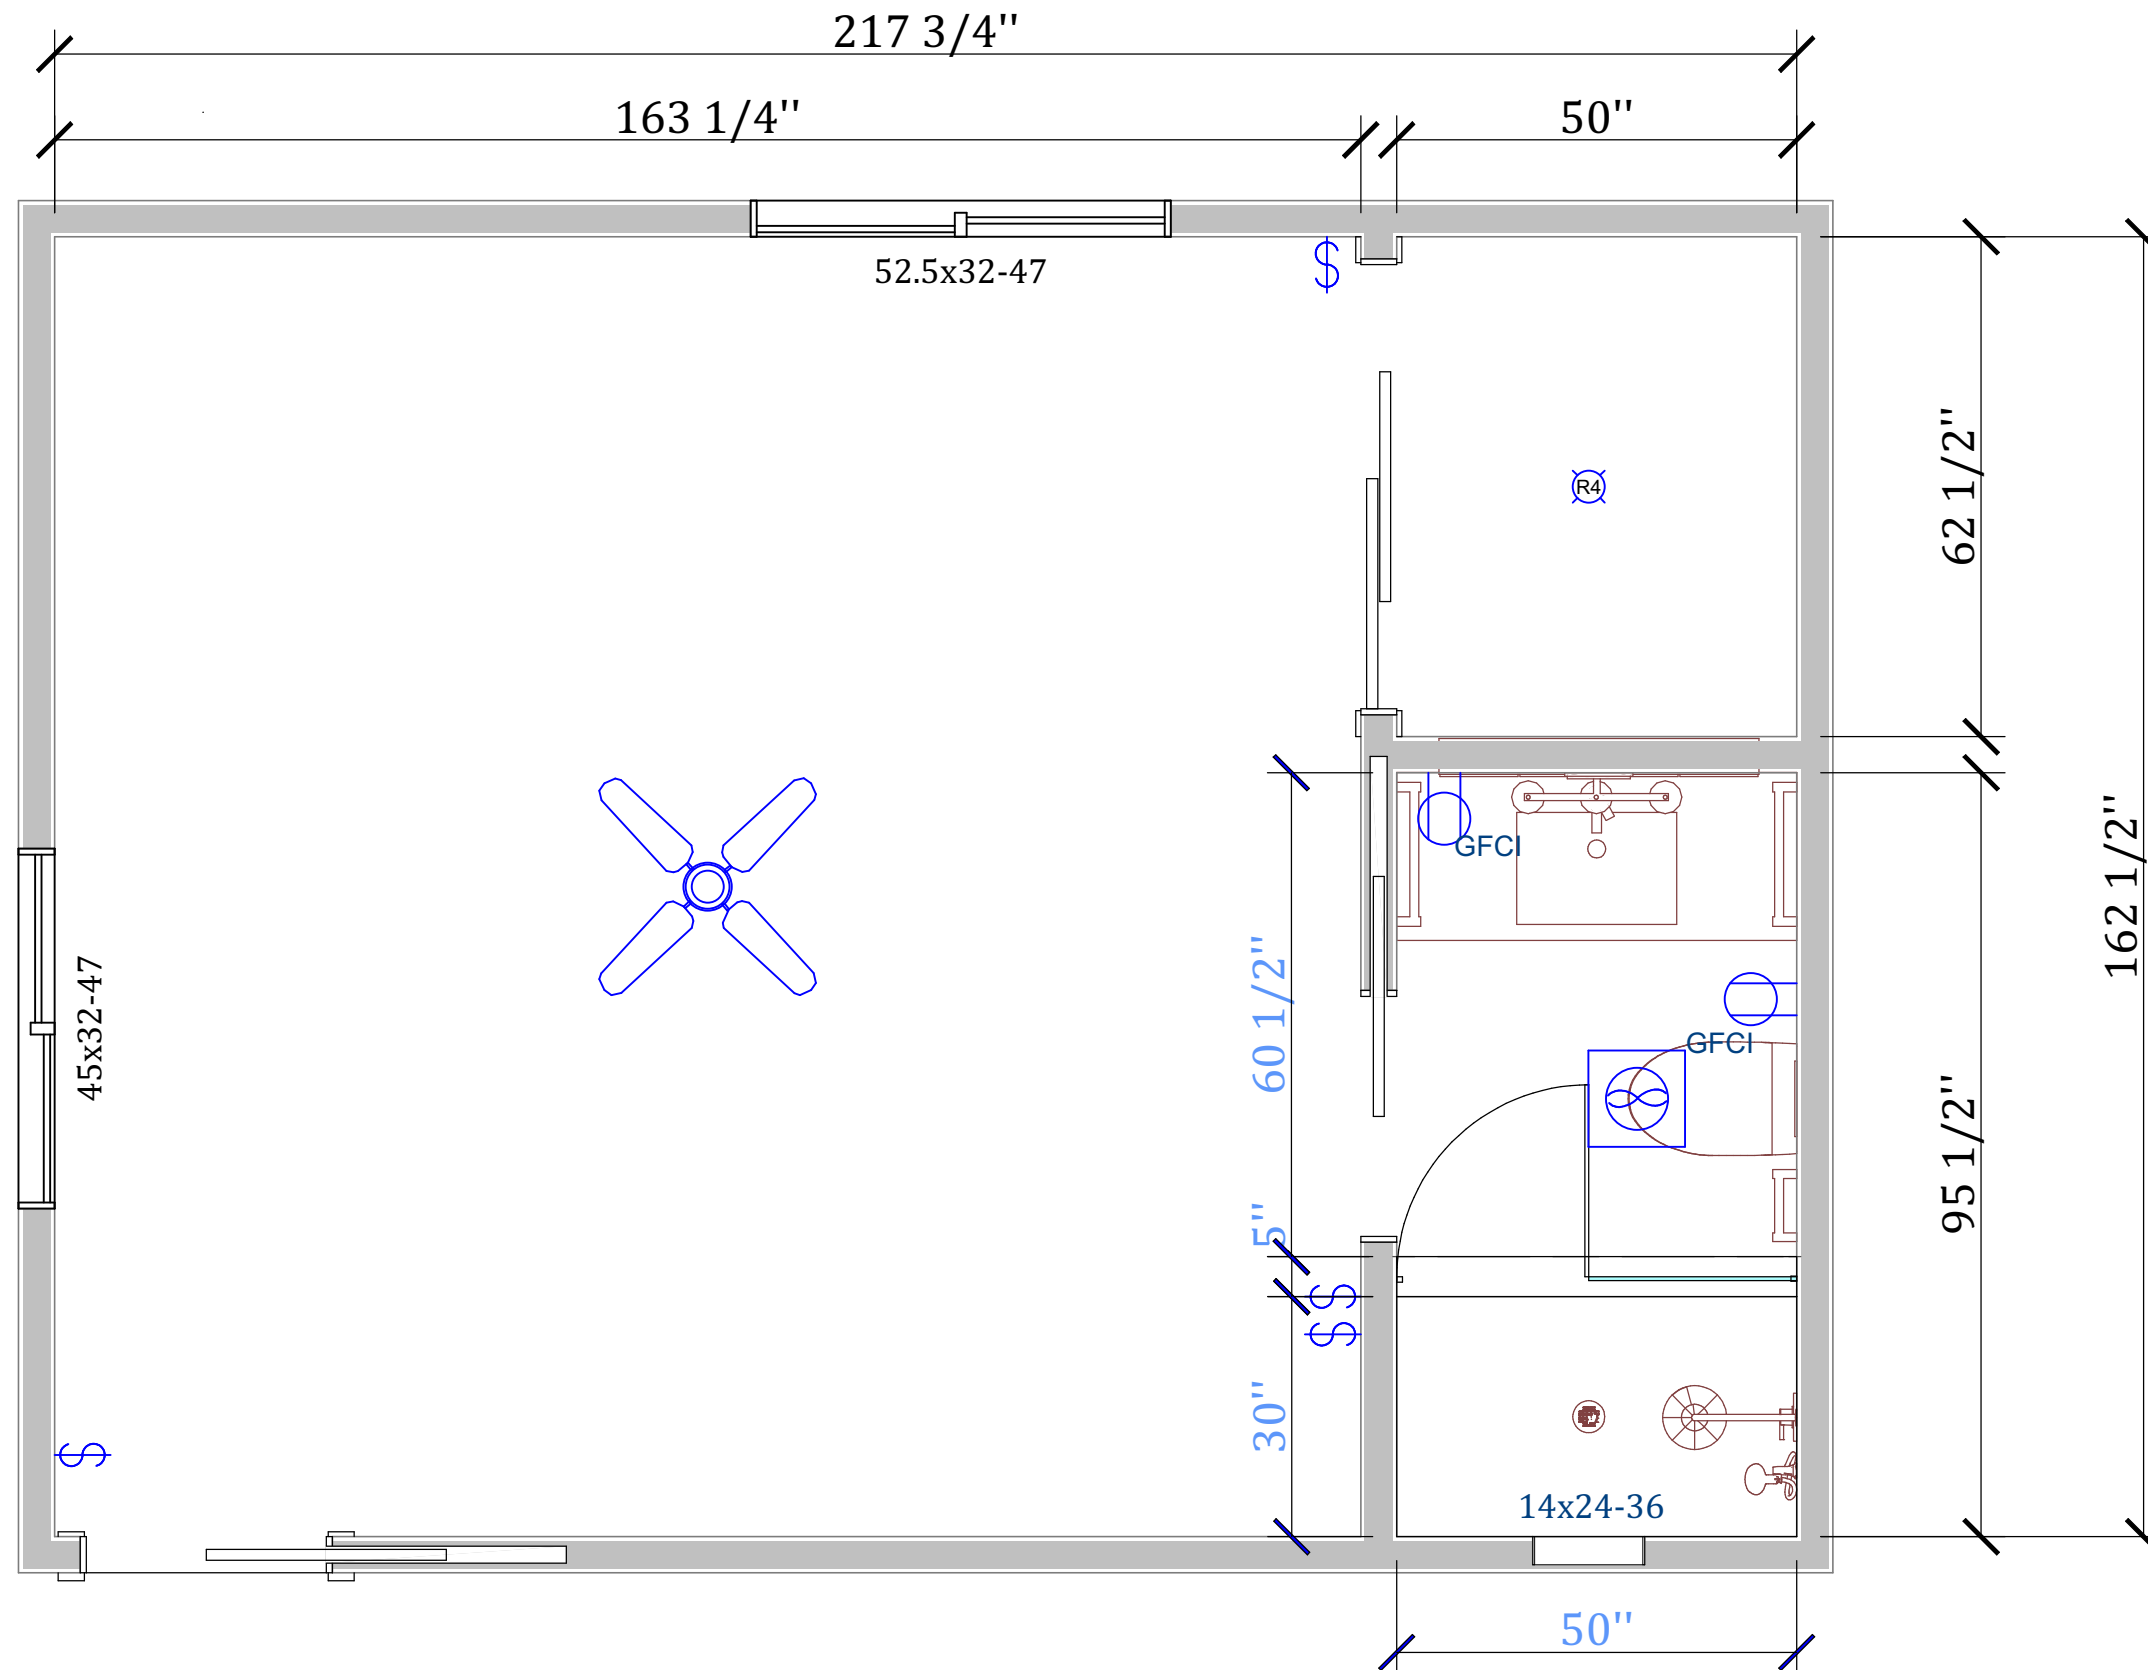

**LEGEND:**

Existing wall

**ELECTRICAL LEGEND:**

- Ⓢ - SWITCH
- ⊕ - OUTLET(GFCI)
- ⊗ - CEILING FAN
- ⊕ - VANITY LIGHT
- ⊗ - VENTILATION FAN
- Ⓡ4 - CEILING MOUNTED LIGHT

Furniture plan

DRAWINGS PROVIDED BY:

DATE:

3/15/2023

SCALE@:

ANSI B  
(11"x17")



SHEET:

A3.0

# ELEVATION PLAN


1/4" = 1'

Verify all dimensions on the field

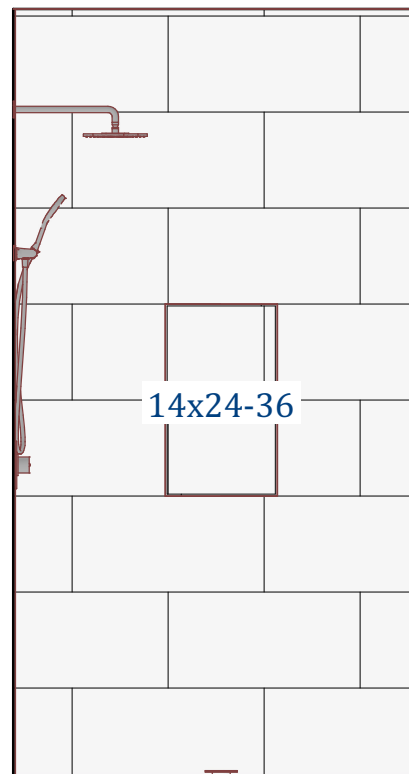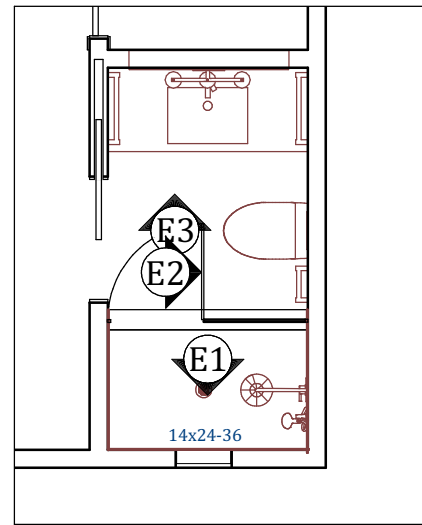


E1 Elevation  
1/2"=1'

Wall tile: Emser,  
Sterlina II 12x24  
polished, horizontal  
50% offset

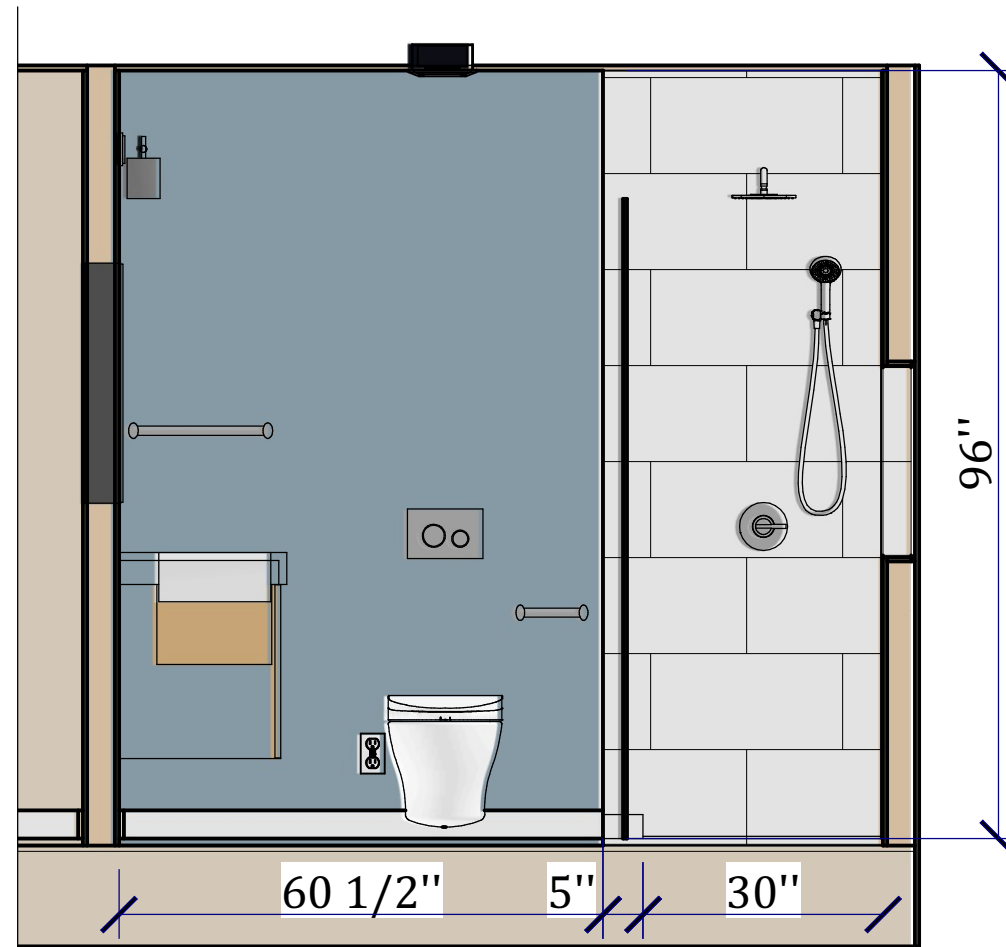

E2 Elevation  
1/2"=1'

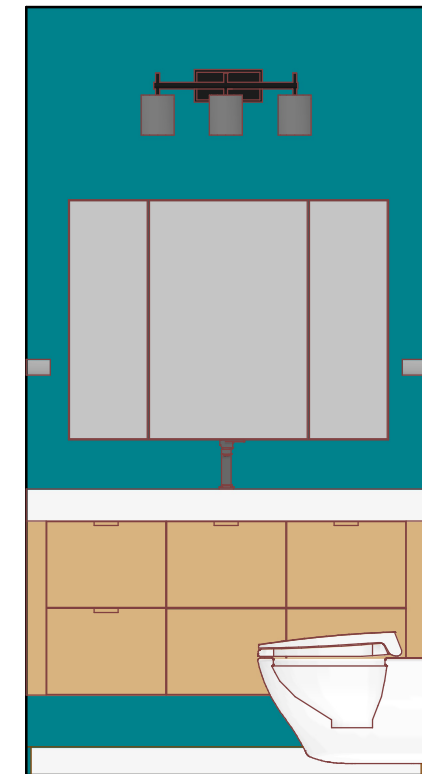

E3 Elevation  
1/2"=1'

# NEW FLOORING PLAN


1/2" = 1'

Verify all dimensions on the field

LEGEND:



Existing wall

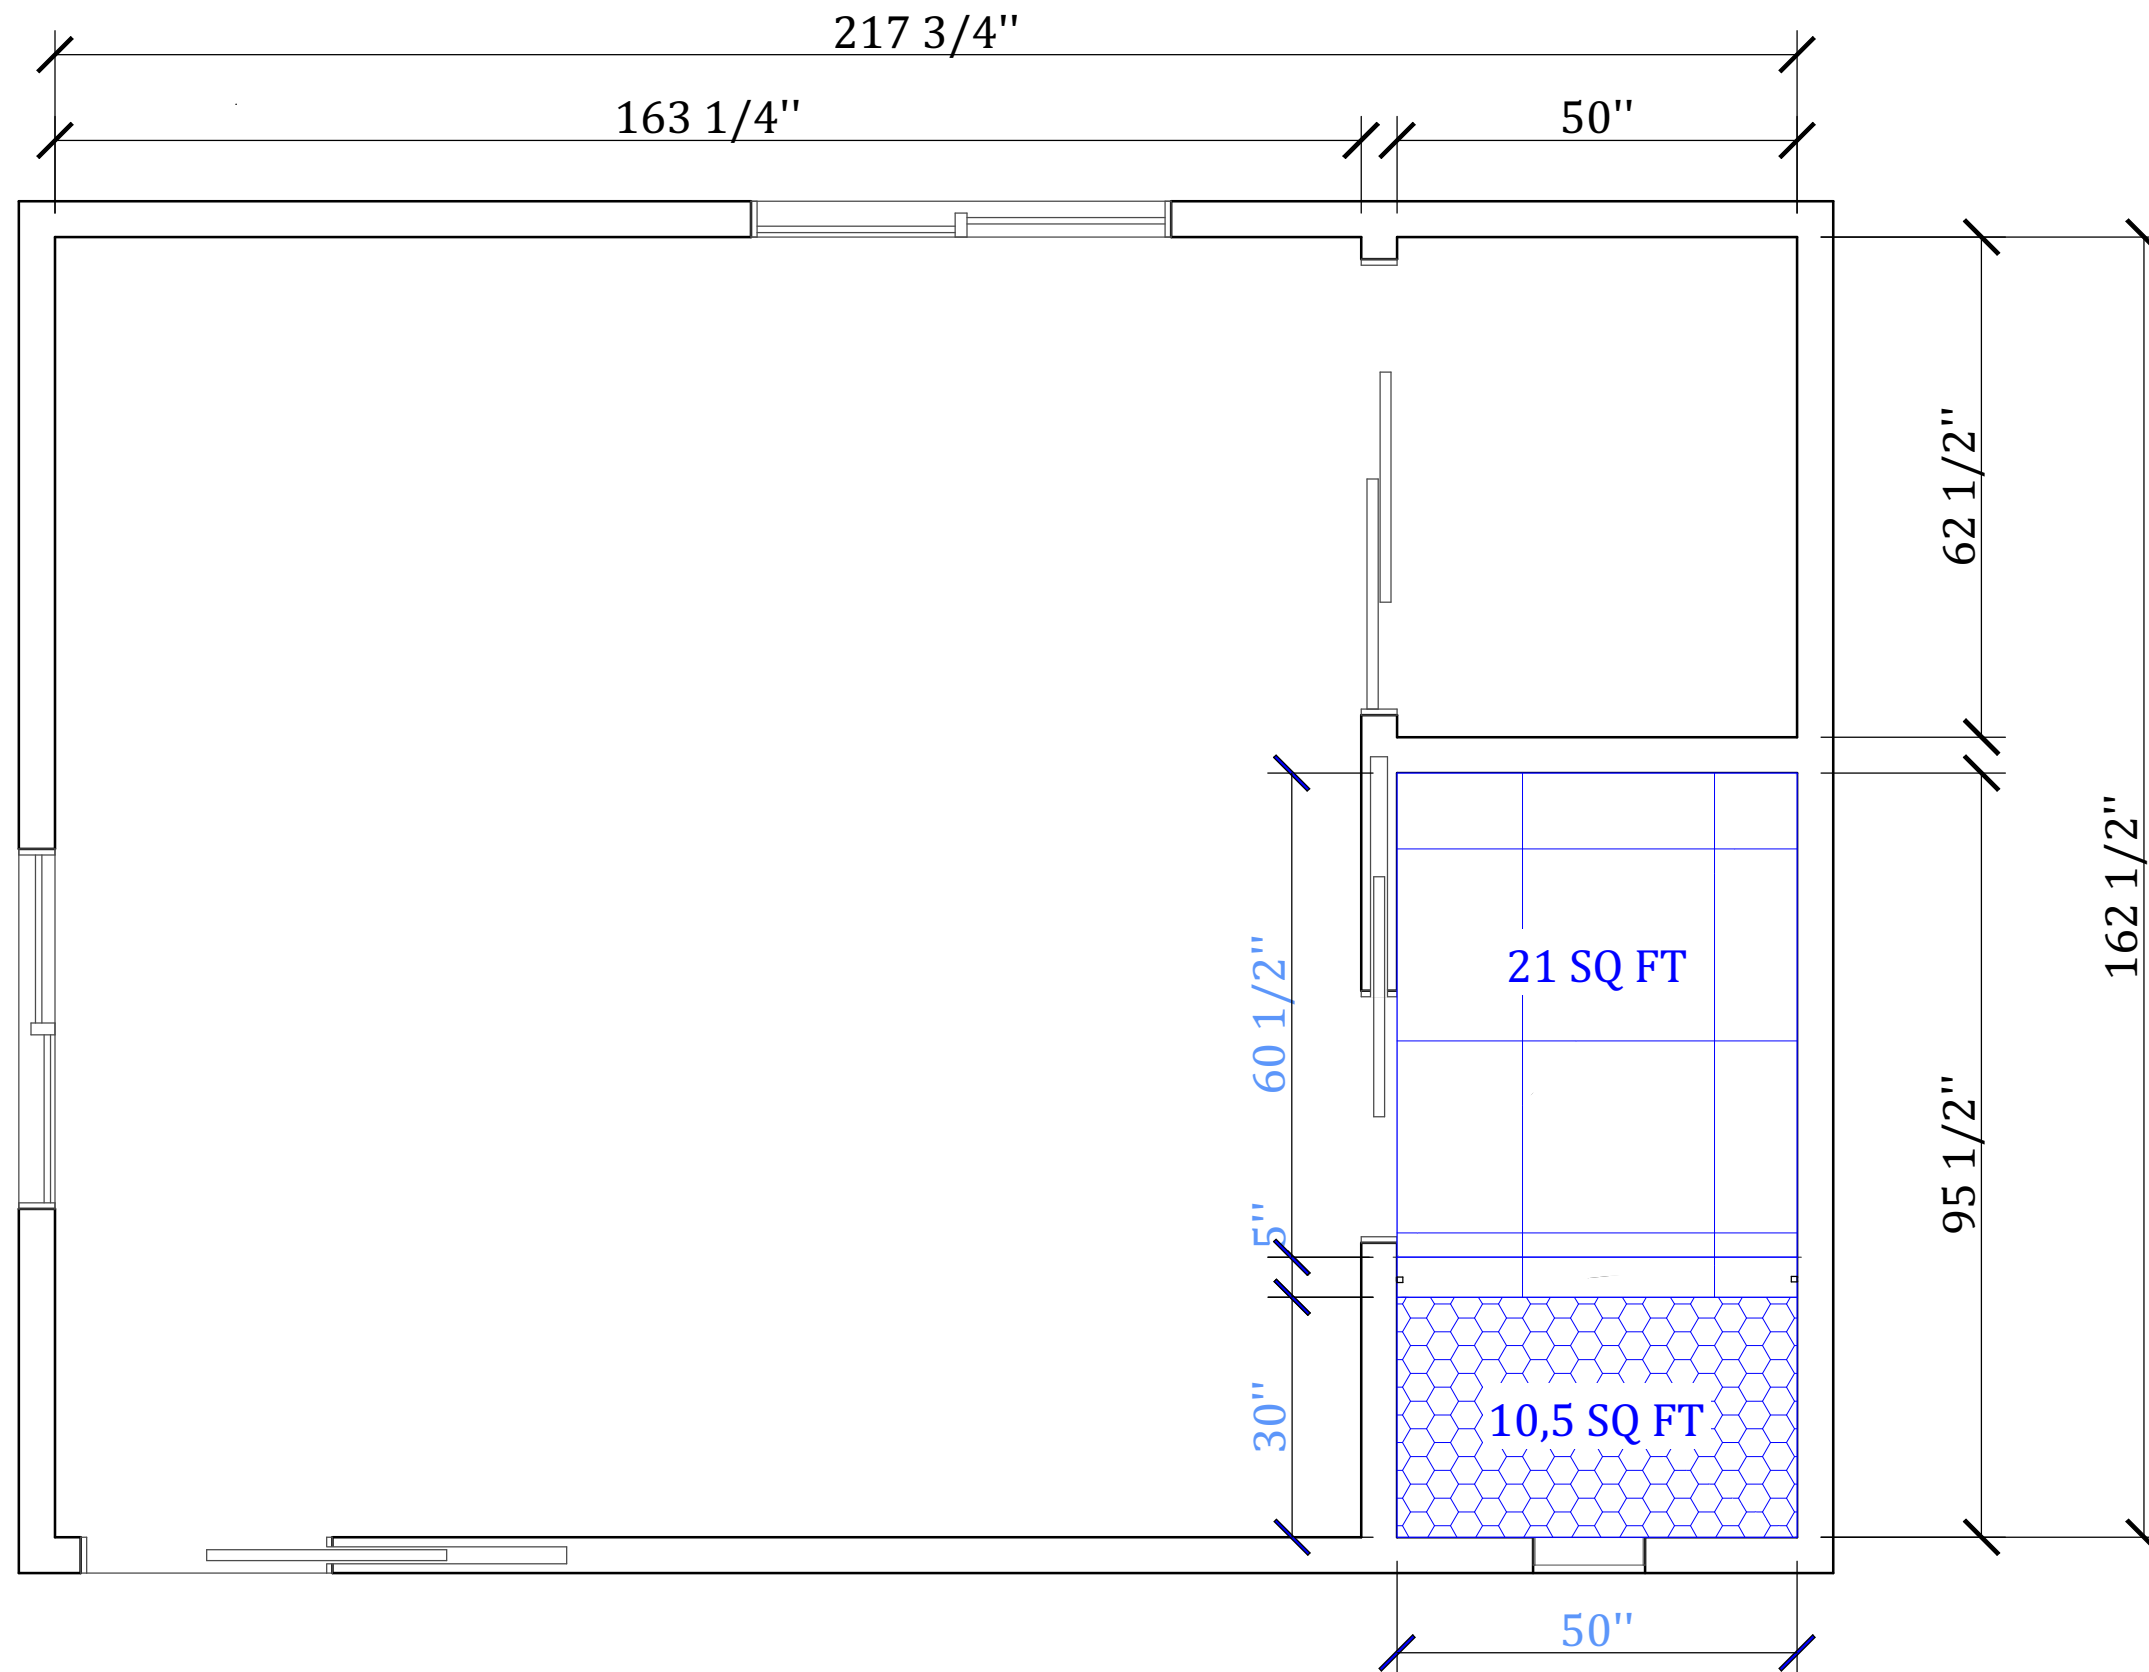

v1.3

DESIGNED BY:  
ROSSLE HOMES  
DESIGN & CONSTRUCTION

New Flooring plan

DRAWINGS PROVIDED BY:

DATE:

3/15/2023

SCALE@:

ANSI B  
(11"x17")

SHEET:

A5.0